




EXISTING GROUND FLOOR PLAN (SCIENCE BLDG.)  
SCALE: 1:100

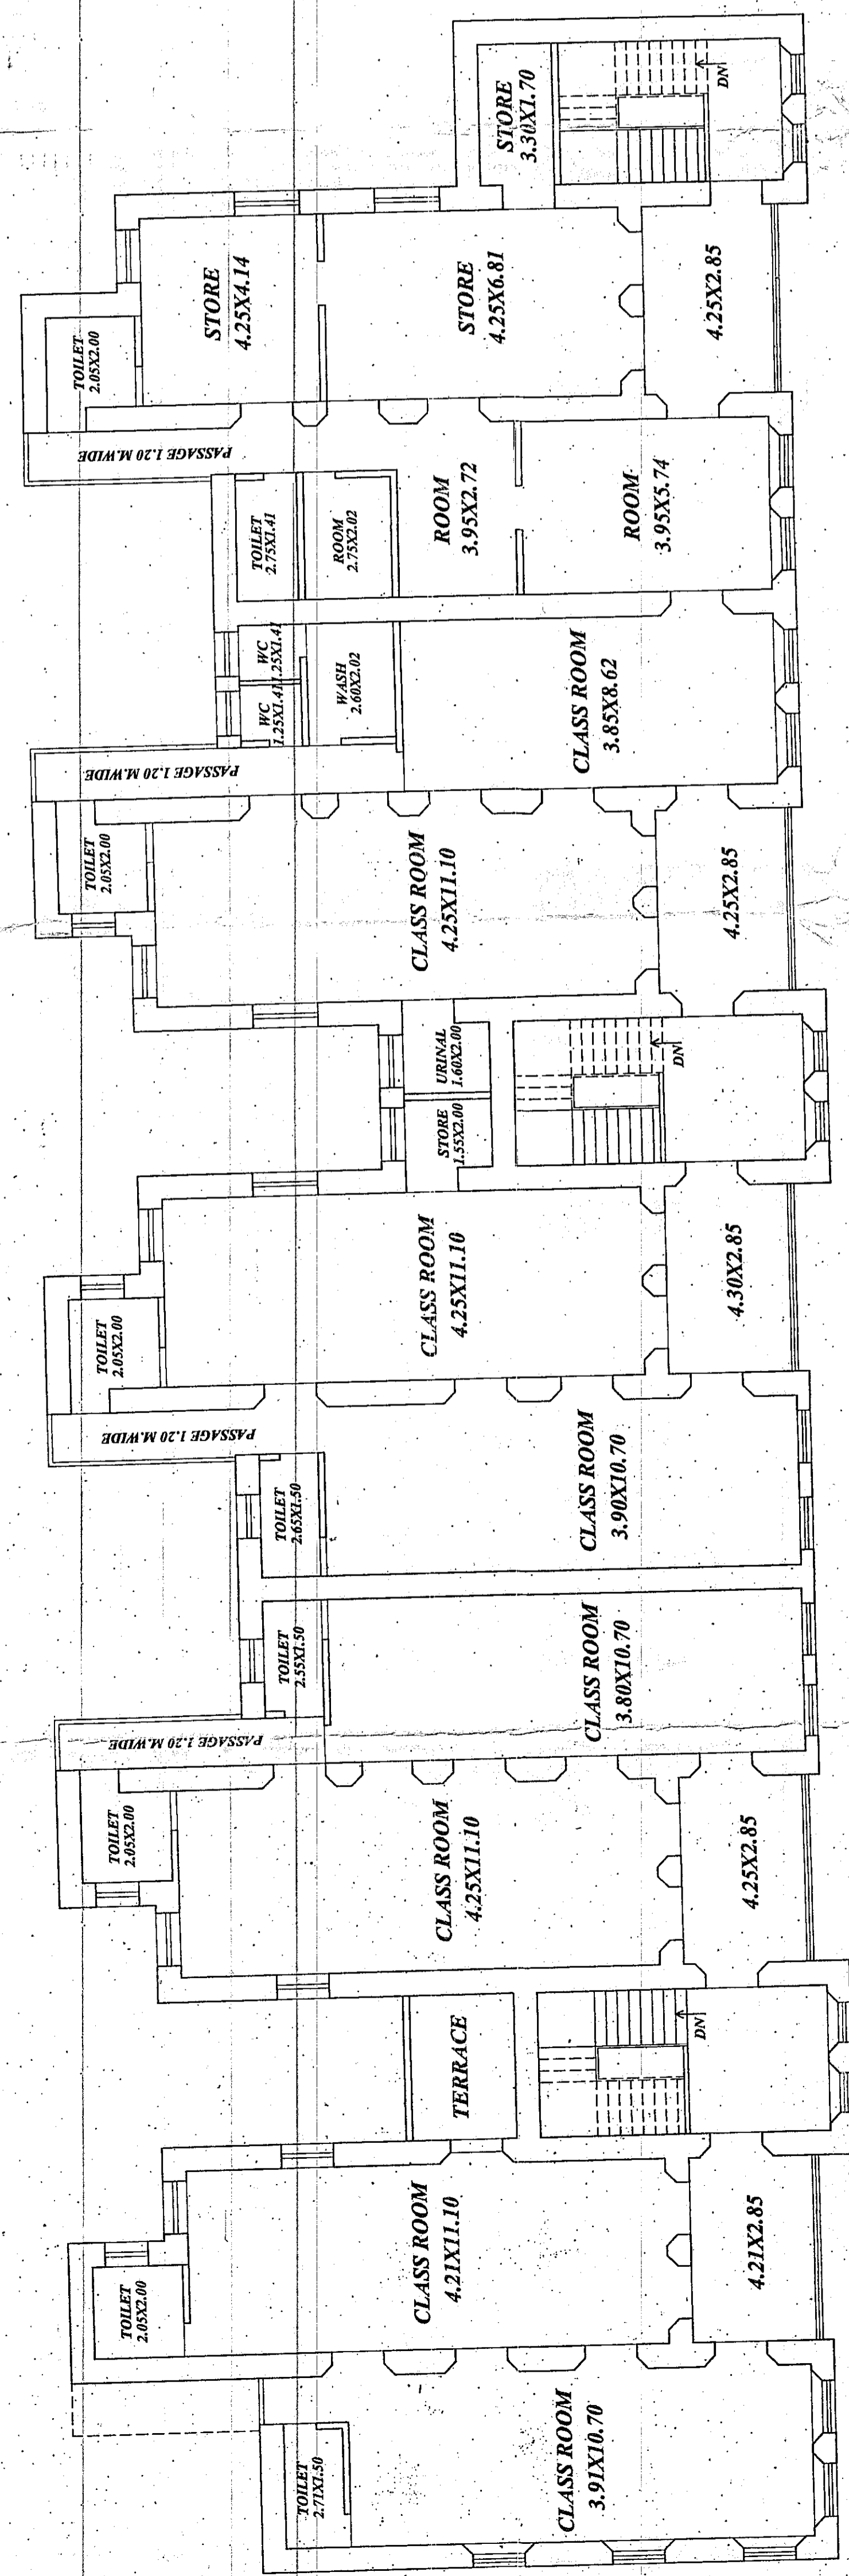


EXISTING FIRST FLOOR PLAN (BLDG. TYPE - A)  
SCALE: 1:100

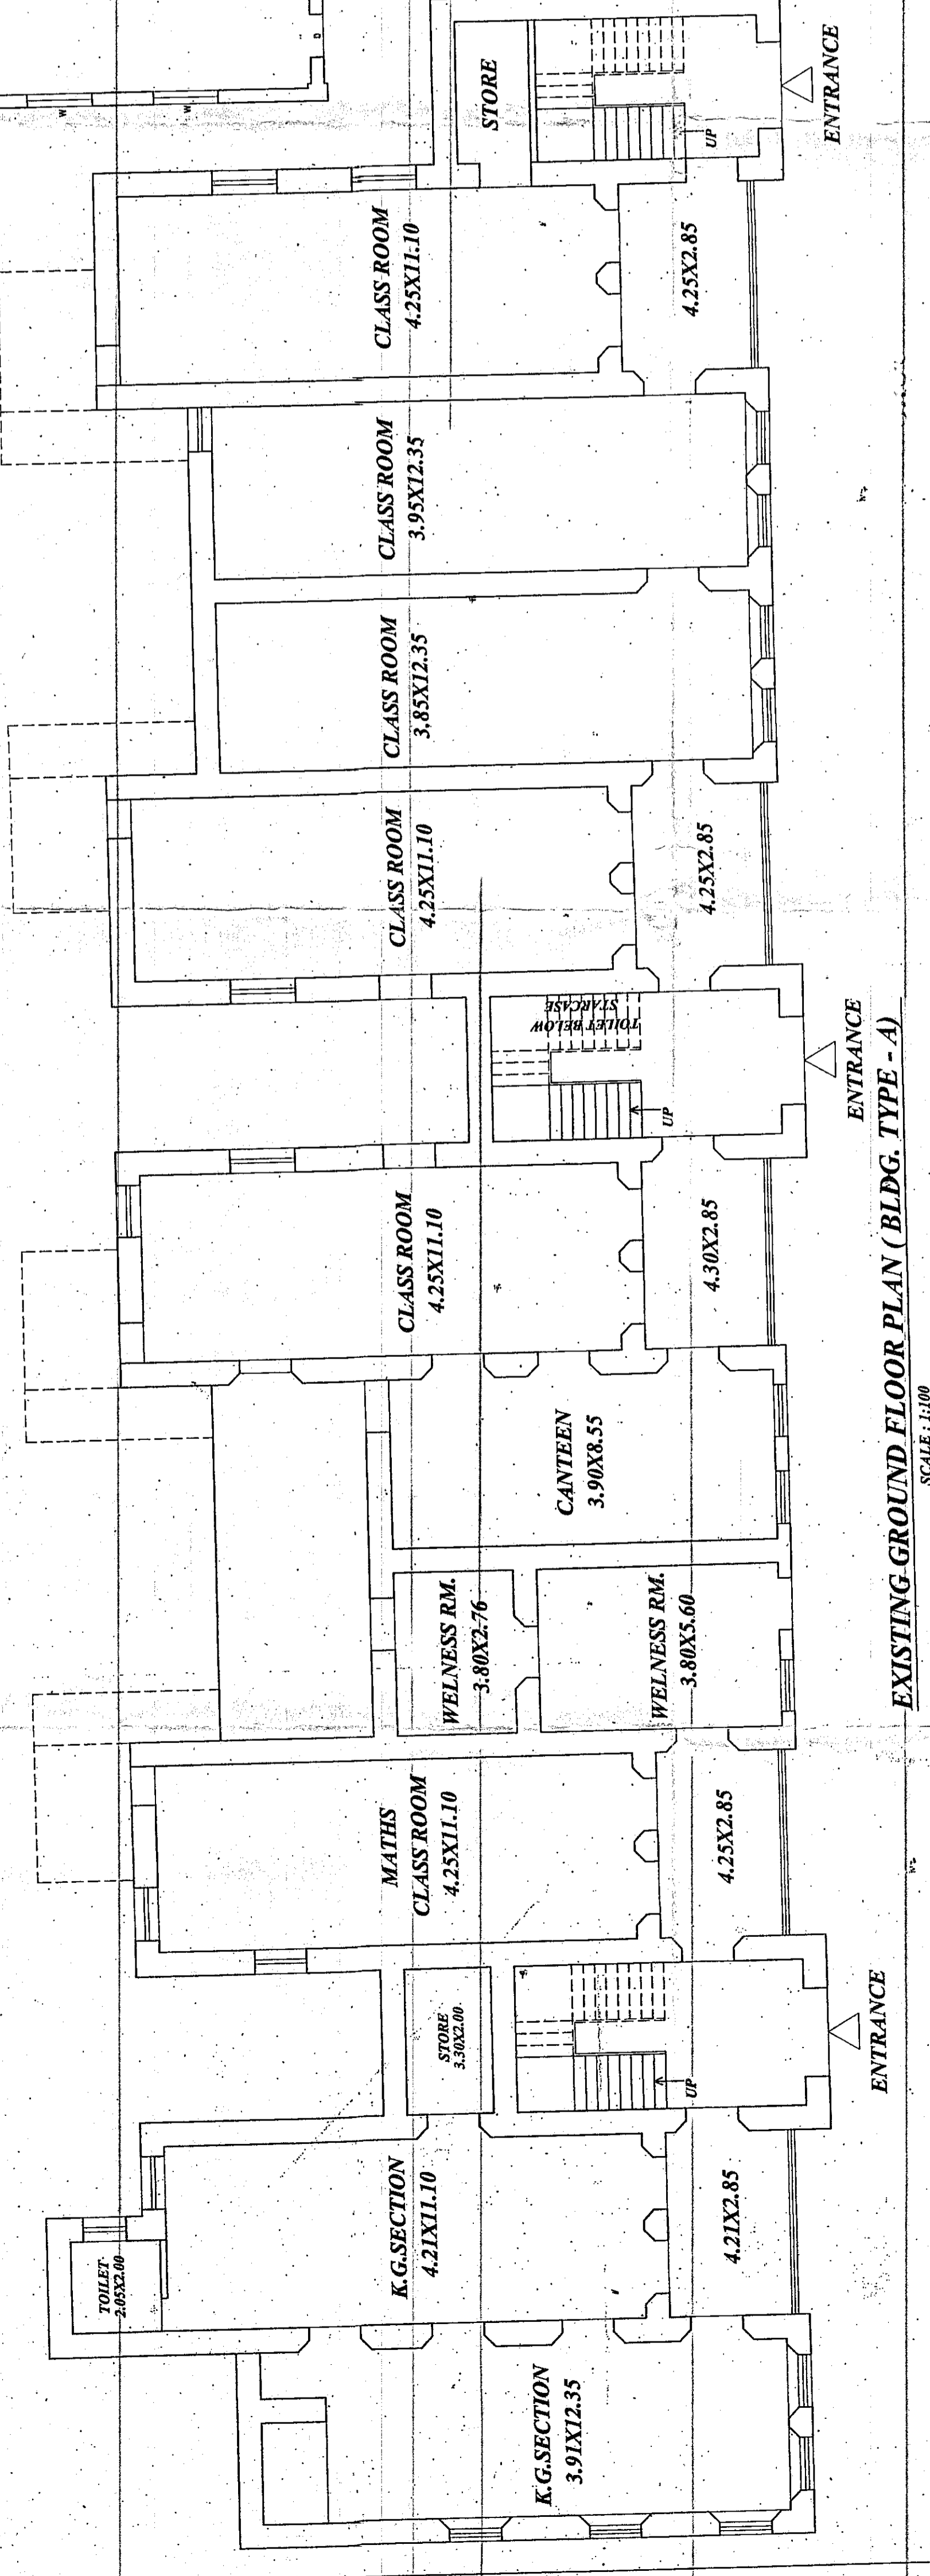

EXISTING GROUND FLOOR PLAN (BLDG. TYPE - A)  
SCALE: 1:100

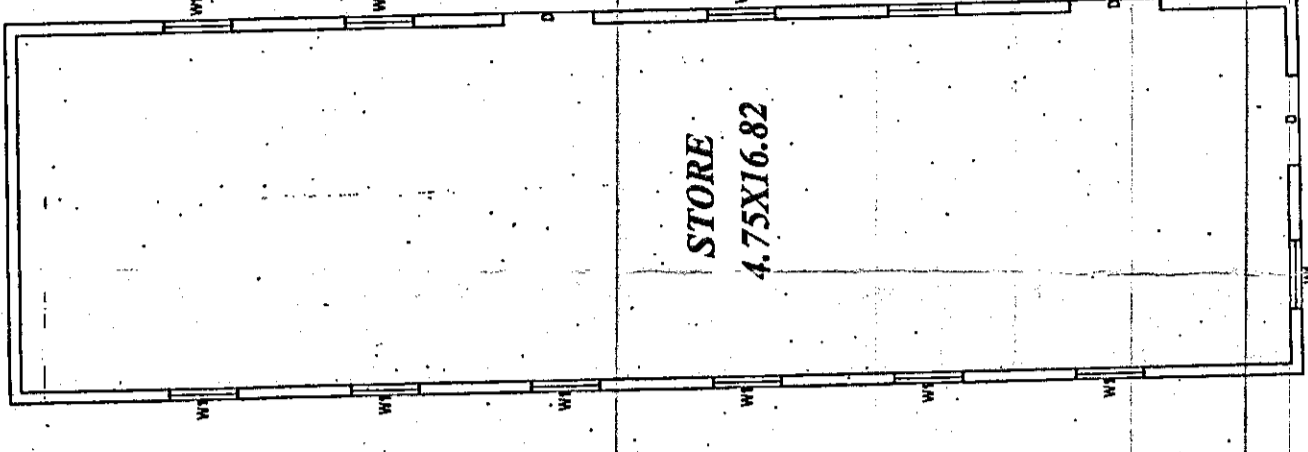

EXISTING GROUND FLOOR PLAN (STORE)  
SCALE: 1:100

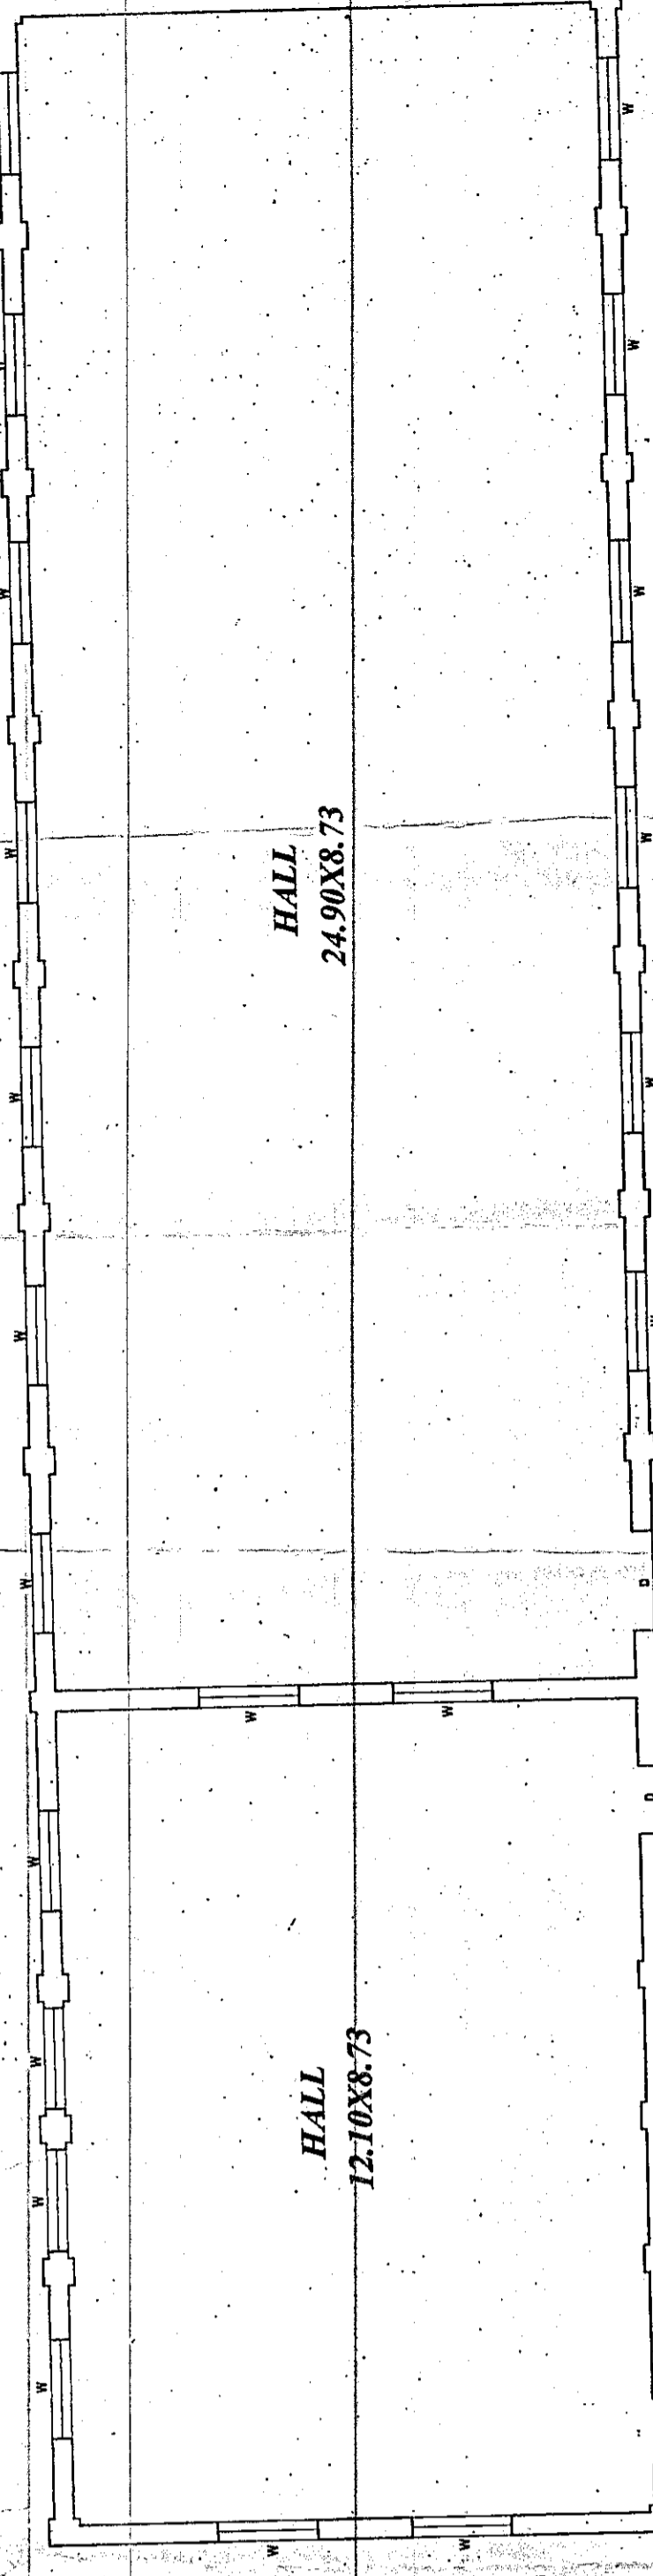

EXISTING GROUND FLOOR PLAN ( HALL )  
SCALE: 1:100

ARCHITECTS & CONSULTANTS  
NORTH

DESCRIPTION OF PROPOSAL & PROPERTY

CENTRAL RAILWAY SCHOOL & JUNIOR COLLEGE, KALYAN.

De-con Consultants  
ARCHITECTS, INTERIOR DESIGNERS,  
REGD. VALUERS & PROJECT CONSULTANTS  
S-1, RAJASHREE TOWER, RAMBAUG, LANE No. 6,  
KALYAN(WEST)-421 304, Tel. 5617899.